


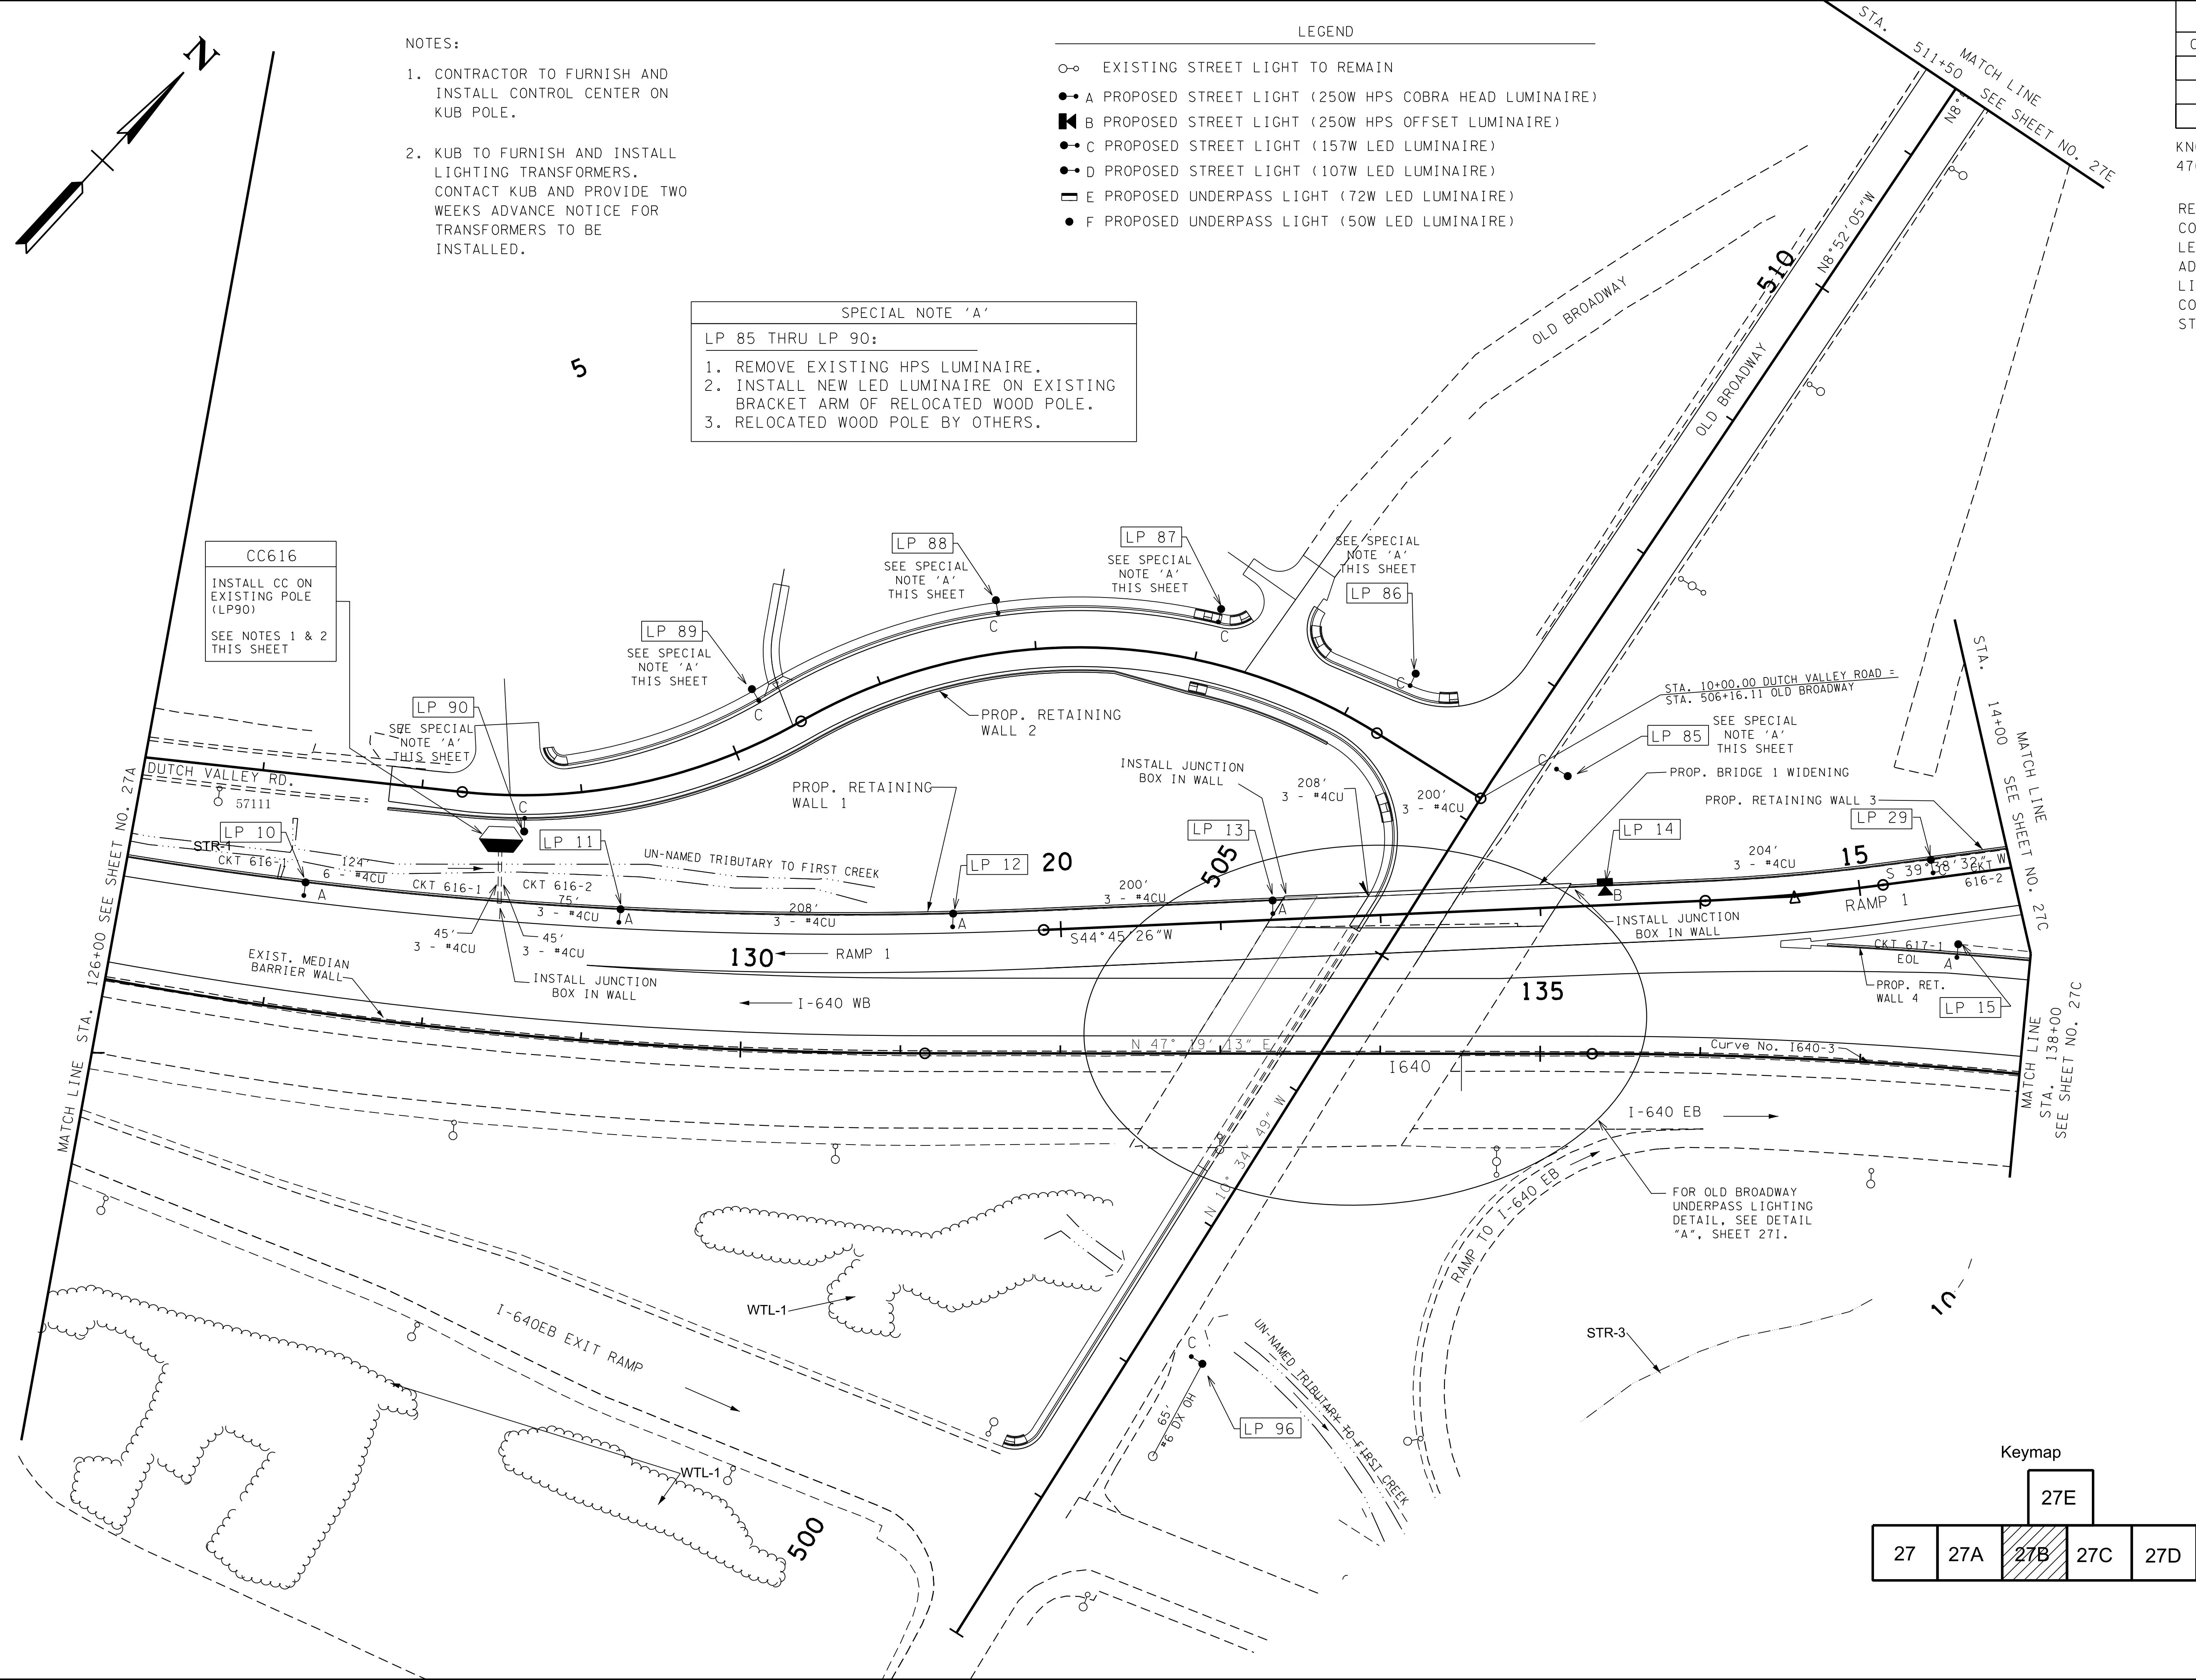

TYPE	YEAR	PROJECT NO.	SHEET NO.
CONST.	2016	NH-I-640-7(161)	27B

KNOX CO. I-640
47008-3150-44 (CONST.)

REV. 01-15-16: UPDATED CONSTRUCTION YEAR. REVISED LEGEND AND SPECIAL NOTE A. ADDED NOTES, UNDERPASS LIGHTING, AND OVERHEAD CONDUCTOR TO LP 96. REMOVED STREET LIGHT REMOVALS.

SEALED BY
JEFF L. MEADOW
REGISTERED ENGINEER
AGRICULTURE
COMMERCIAL
No. 20099
STATE OF TENNESSEE

REBECCA C. BOTTOMS
REGISTERED ENGINEER
AGRICULTURE
COMMERCIAL
No. 20099
STATE OF TENNESSEE

COORDINATES ARE NAD/83(1995), ARE DATUM ADJUSTED BY THE FACTOR OF 1.0001 AND TIED TO THE TGRN. ALL ELEVATIONS ARE REFERENCED TO THE NAVD 1988.

STATE OF TENNESSEE
DEPARTMENT OF TRANSPORTATION

LIGHTING LAYOUT
I-640, OLD BWAY
STA. 126+00 TO STA. 138+00
SCALE: 1"= 50'