


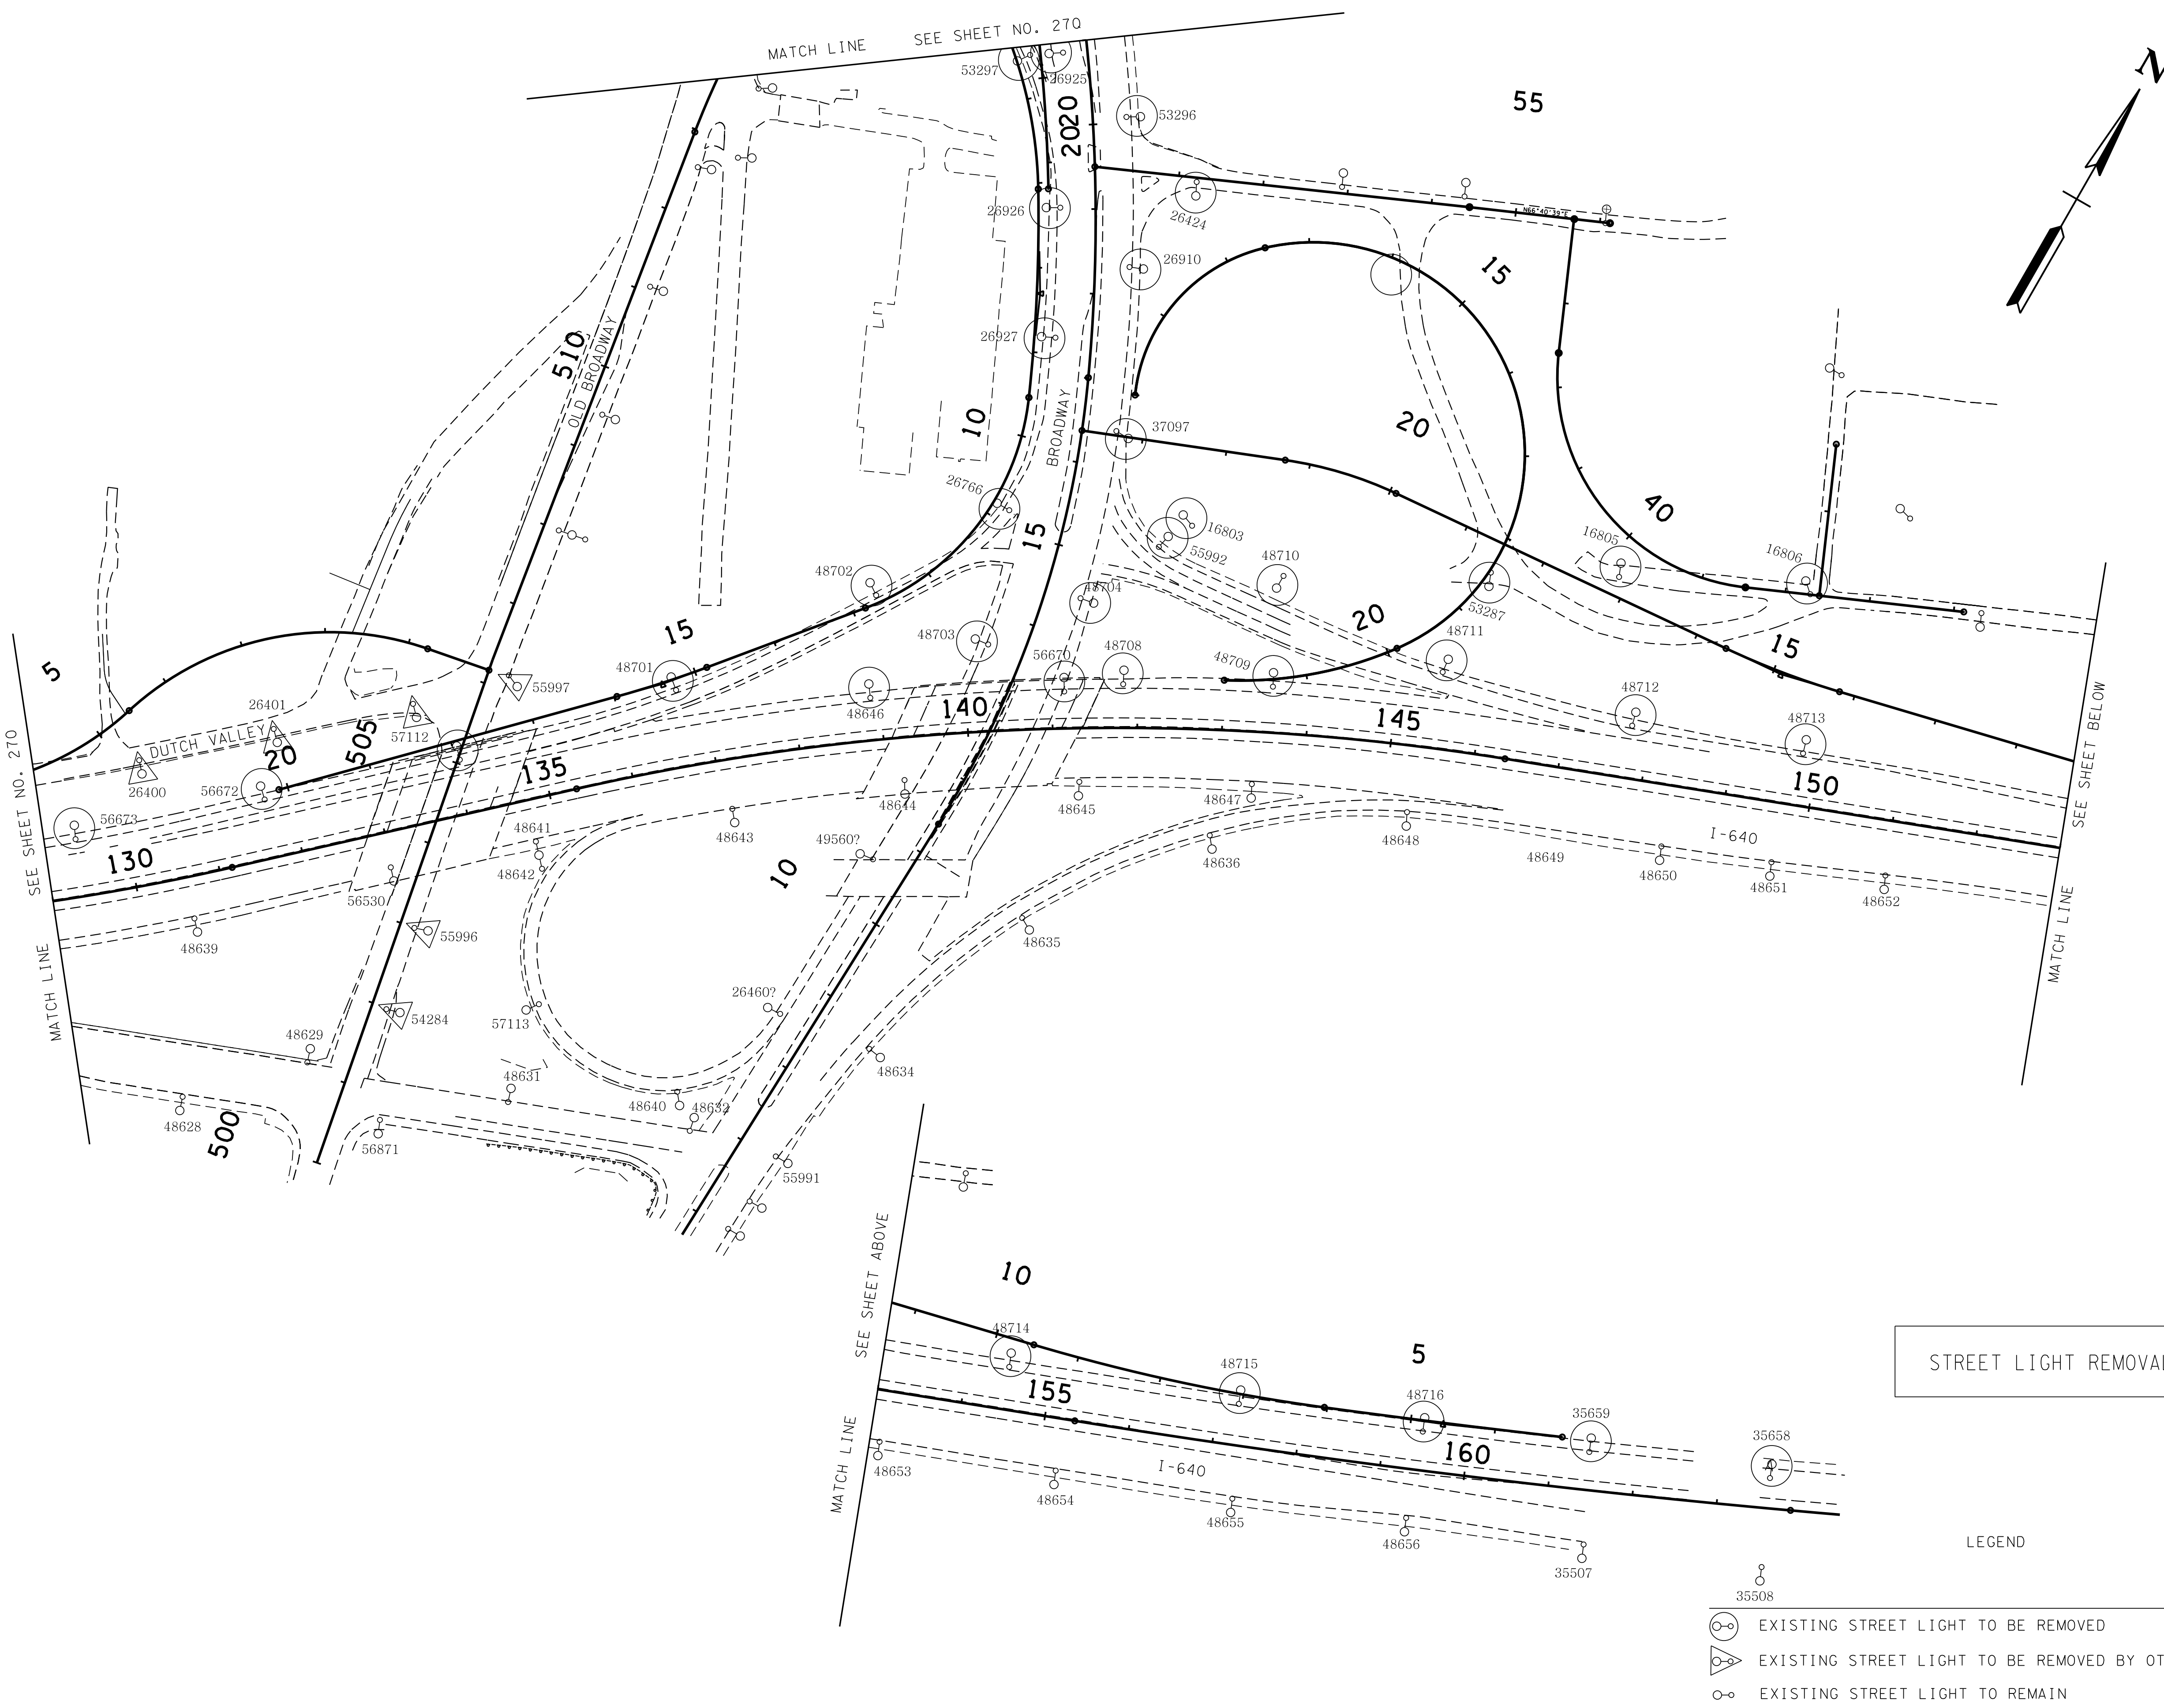


STREET LIGHT REMOVALS

35508

- EXISTING STREET LIGHT TO BE REMOVED
- EXISTING STREET LIGHT TO BE REMOVED BY OTHERS
- EXISTING STREET LIGHT TO REMAIN

LEGEND

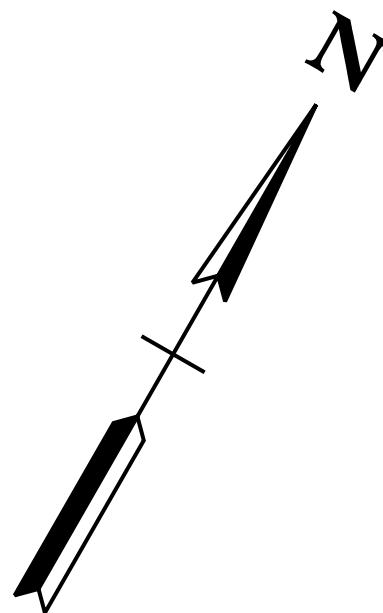

TYPE	YEAR	PROJECT NO.	SHEET NO.
CONST.	2016	NH-I-640-7(161)	27P

KNOX CO. I-640
47008-3150-44 (CONST.)
REV. 01-15-16: ADDED SHEET TO PLANS.

SEALED BY

COORDINATES ARE NAD/83(1995), ARE DATUM ADJUSTED BY THE FACTOR OF 1.0001 AND TIED TO THE TGRN. ALL ELEVATIONS ARE REFERENCED TO THE NAVD 1988.

STATE OF TENNESSEE
DEPARTMENT OF TRANSPORTATION

LIGHTING LAYOUT
I-640

SCALE: 1"= 100'